




ROOF PLAN — HVAC  
SCALE 1/4" = 1' — 0" WHEN PLOTTED 36" X 24"

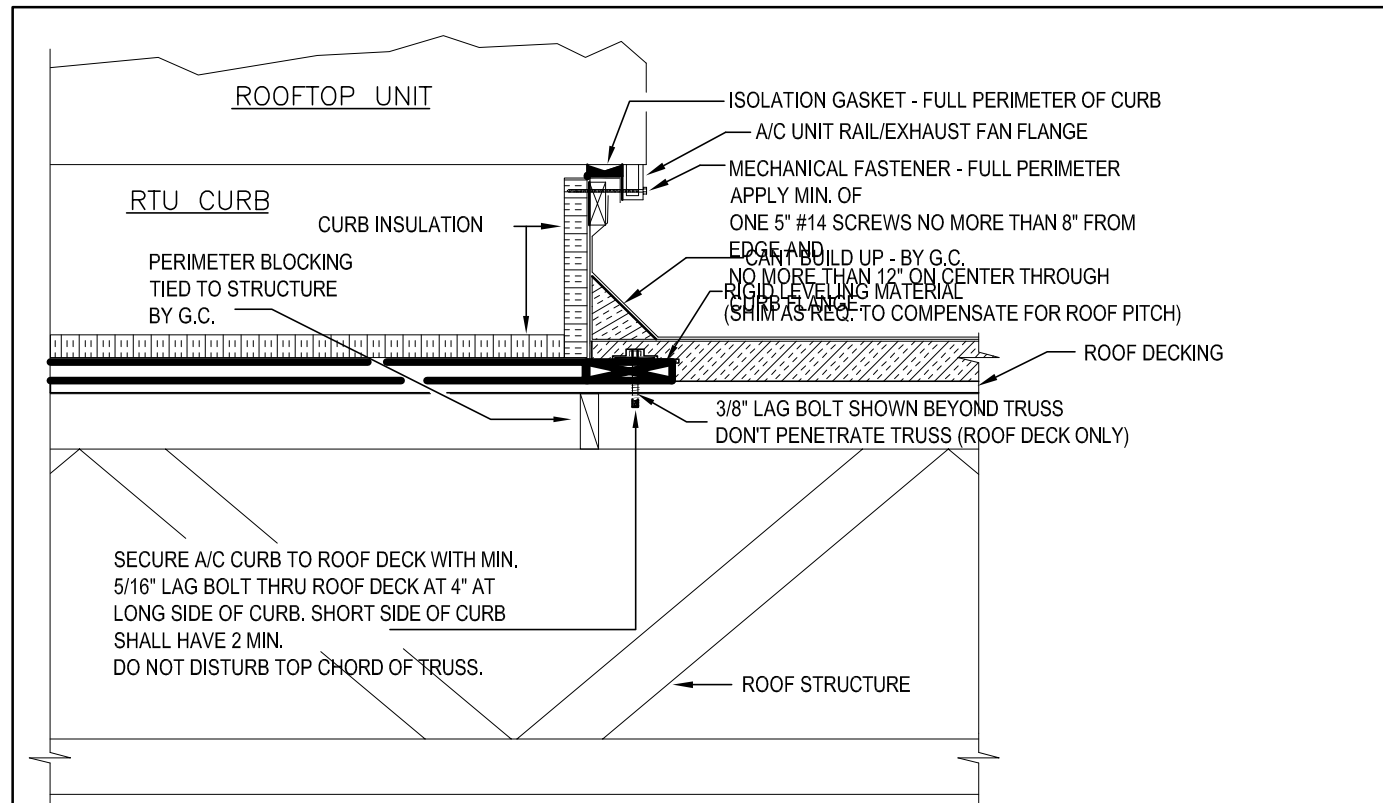


CURB EQUIPMENT ATTACHMENT DETAIL  
NOT TO SCALE

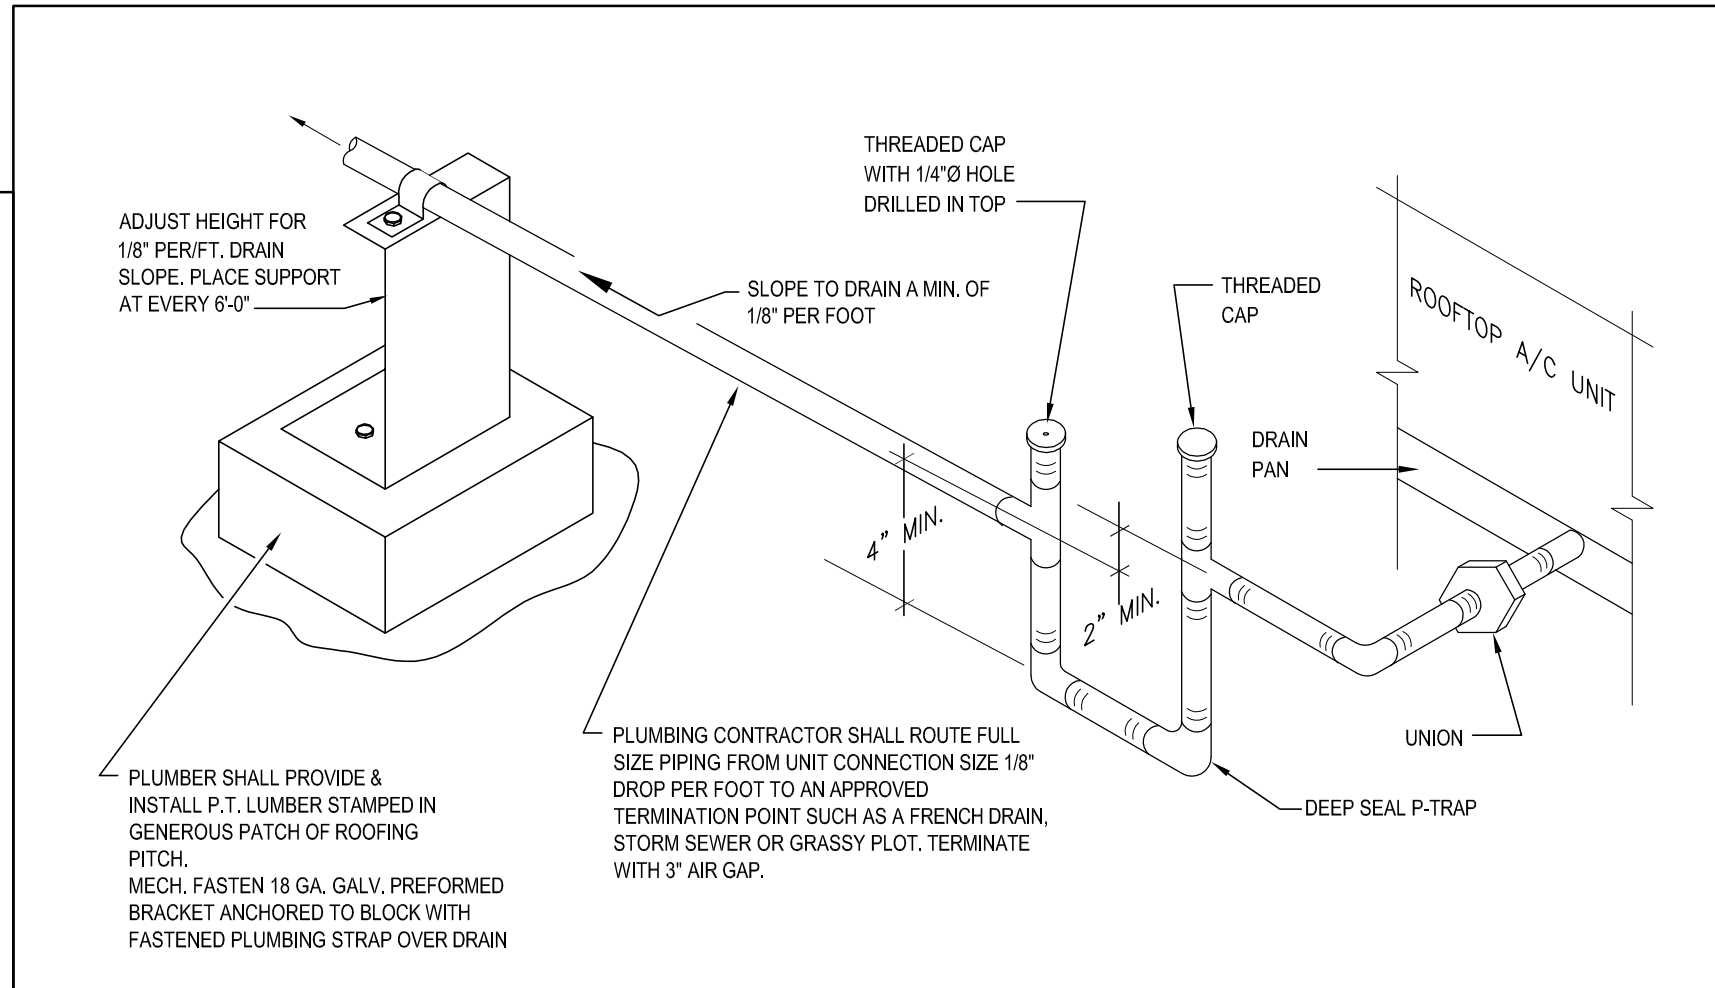


CONDENSATE P-TRAP DETAIL  
NOT TO SCALE

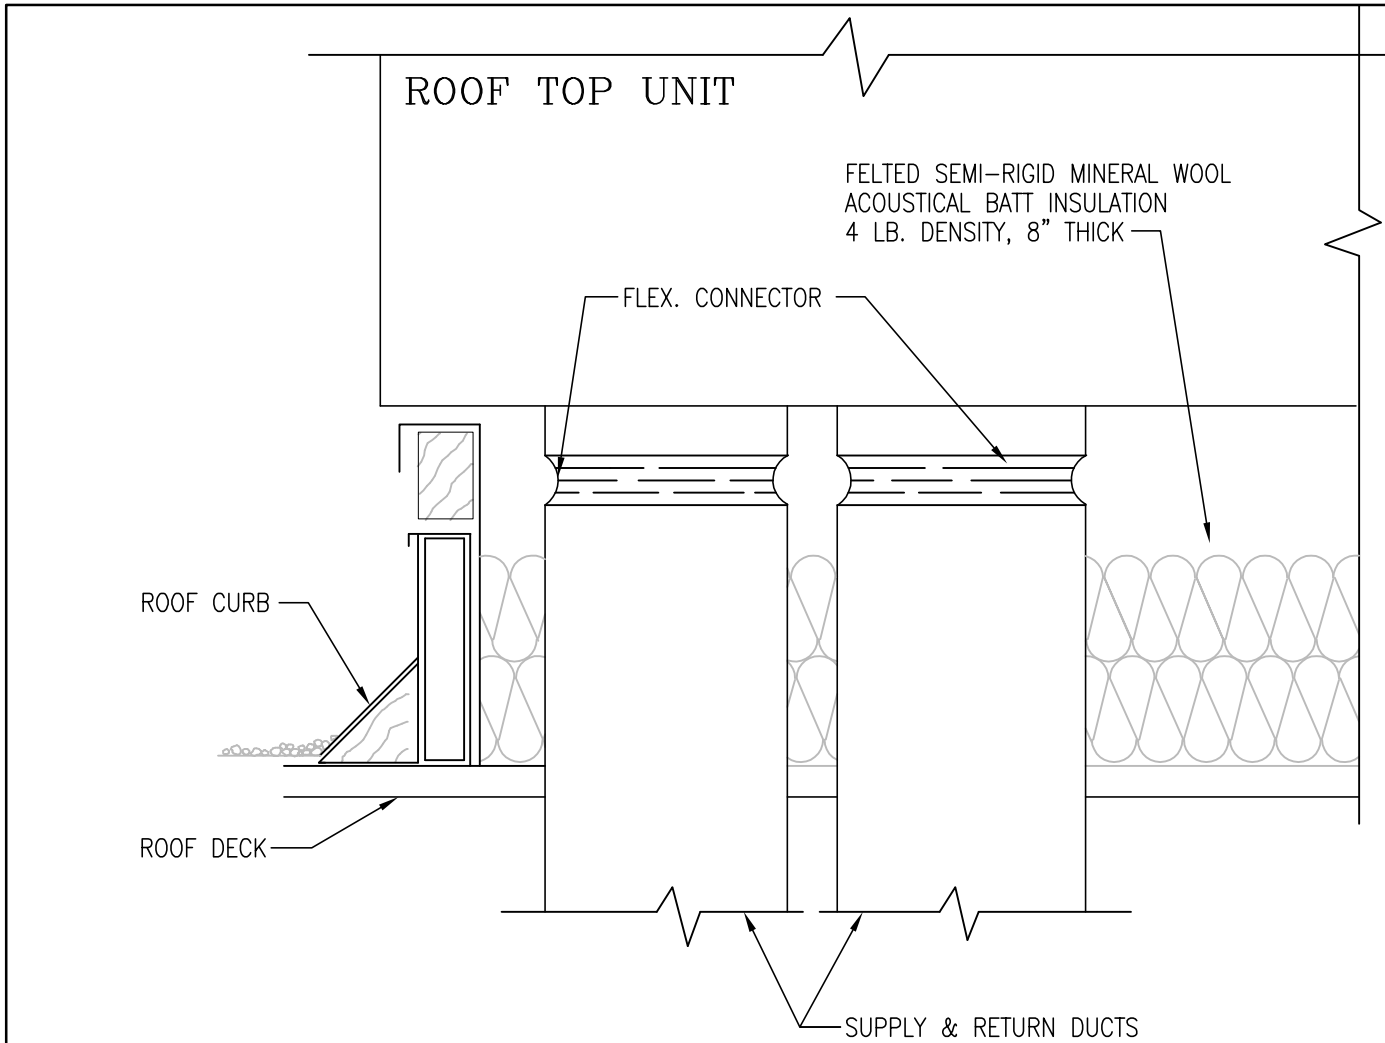


ROOFTOP UNIT DETAILS  
NOT TO SCALE

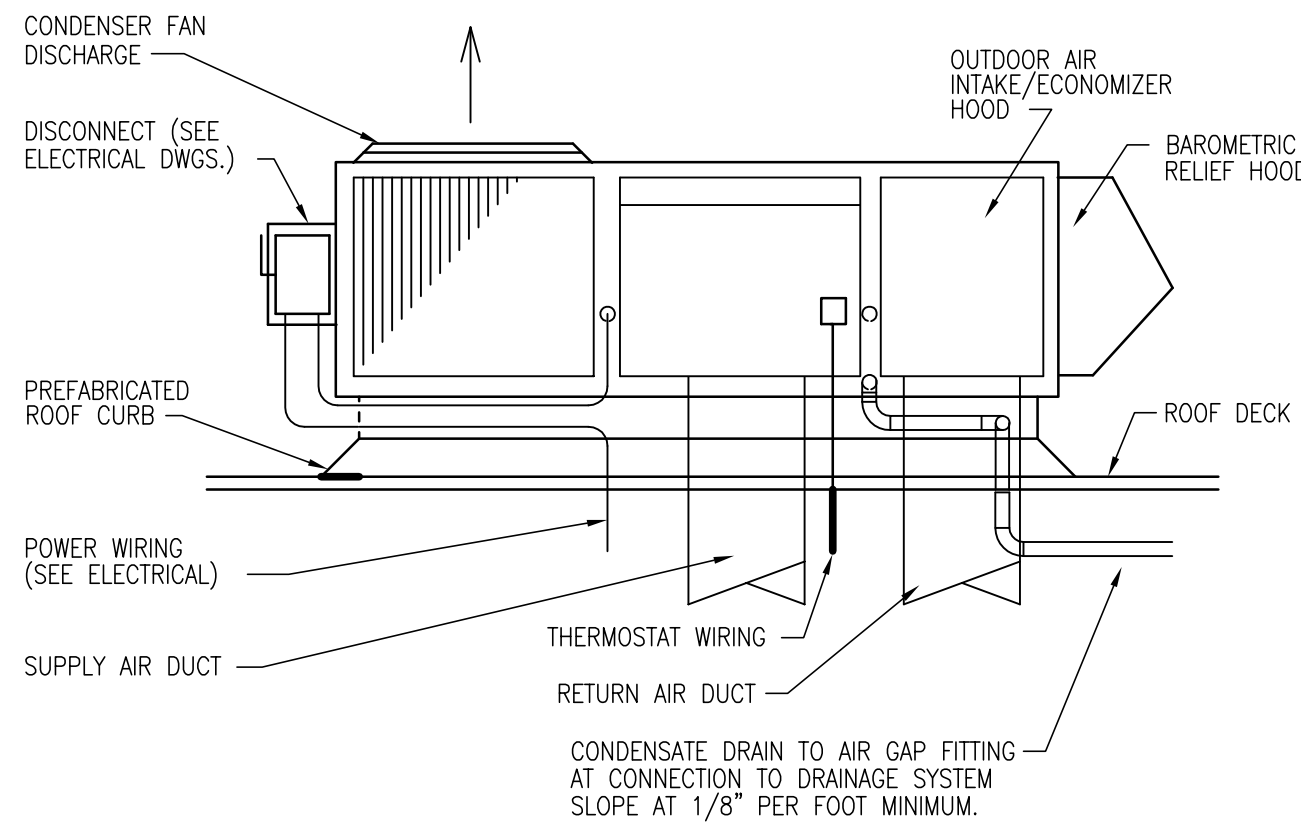

NOTE: ALL CONNECTIONS AND SERVICES MUST BE INSIDE THE PERIMETER CURB. DISCONNECT SWITCHES, BRACKETS, AND CONDUIT MUST BE CLEAR OF ALL UNIT PANELS AND AIR FLOW. BRACKETS MUST BE TO STRUCTURAL MEMBERS OF UNIT.

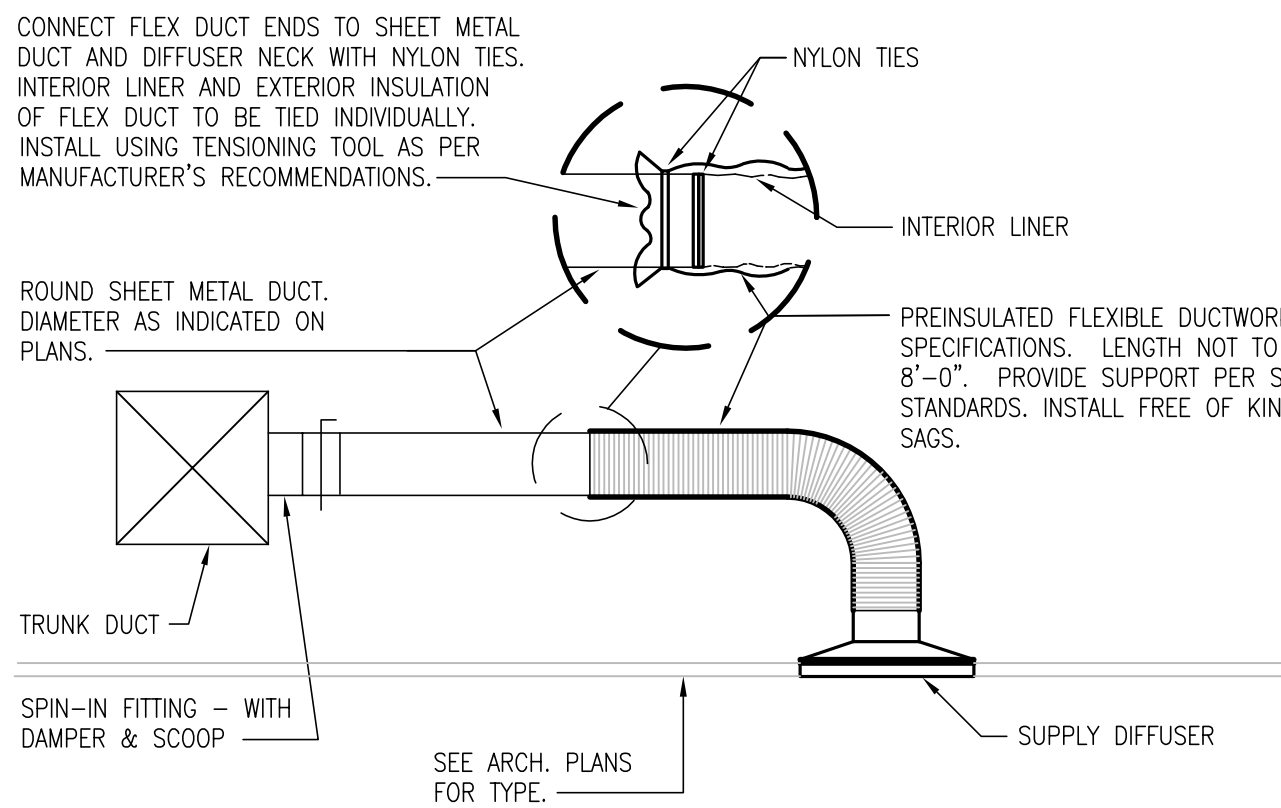

FLEXDUCT CONNECTION/INSTALL DETAIL  
NOT TO SCALE

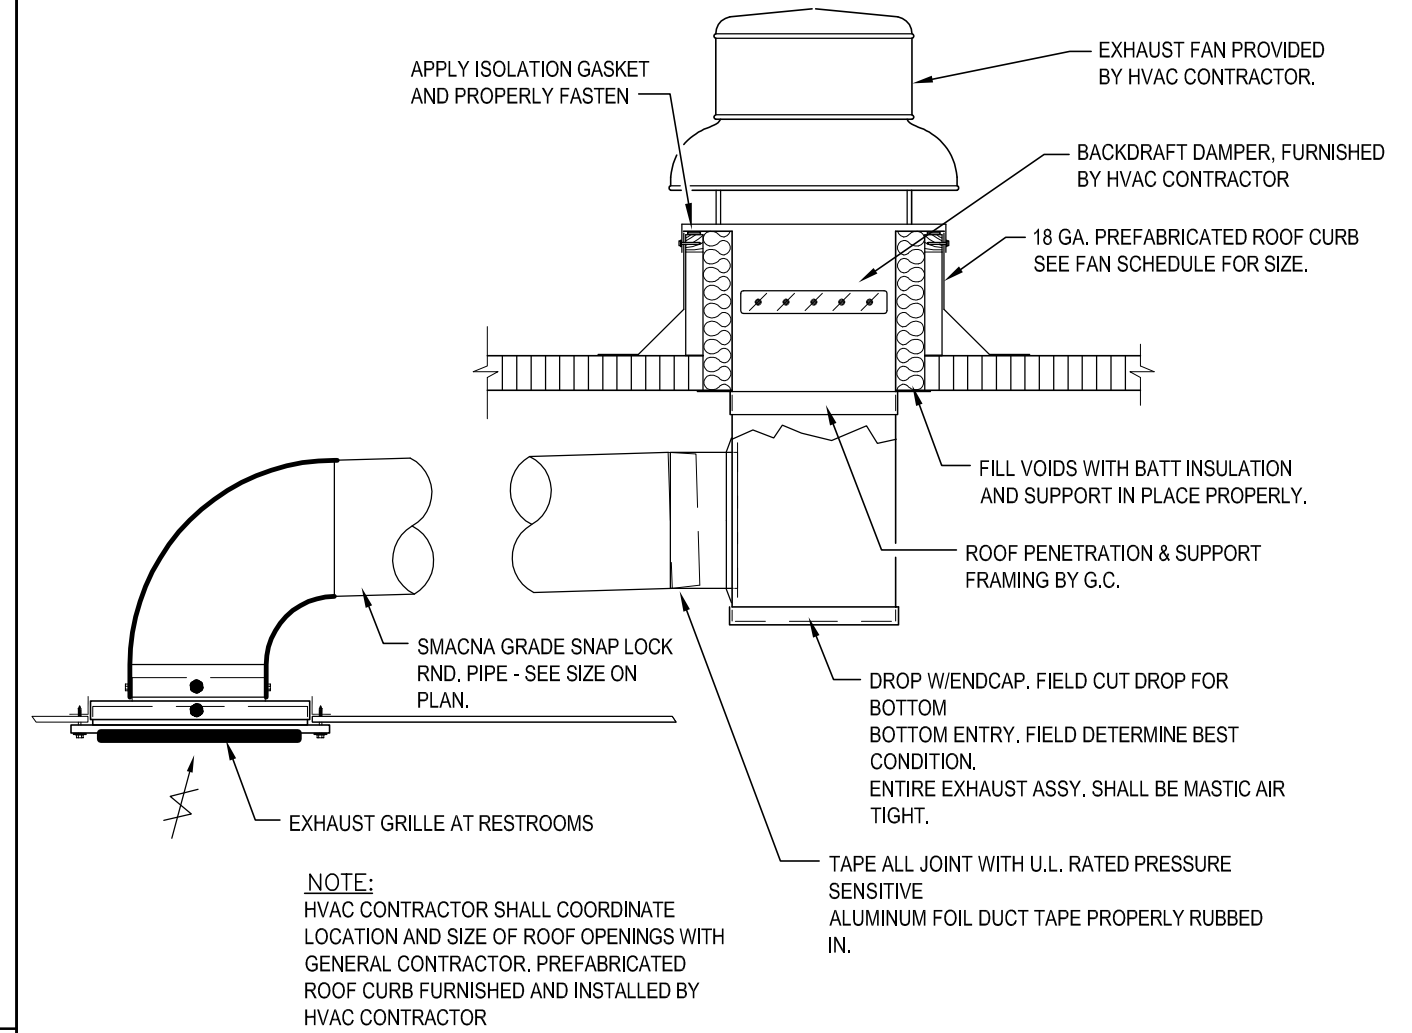

EXHAUST FAN DETAIL - TYP.  
NOT TO SCALE

POPEYES

400 PERIMETER CENTER TERRACE  
SUITE 1000  
ATLANTA, GA 30346  
404-584400

THESE DRAWINGS ARE THE  
PROPERTY OF  
POPEYES / APC ENTERPRISES, INC.  
AND SHALL NOT BE USED OR  
REPRODUCED WITHOUT THE  
EXPRESS WRITTEN PERMISSION  
FROM THE OWNER.

MRP  
DESIGN GROUP

3450 Acworth Due West Road  
Building 100, Suite 120  
Kennesaw, Georgia 30144  
P. 770-917-9172  
F. 770-917-9470  
www.mrpdesign.com

ARCHITECT OF RECORD:  
THOMAS E. MORGAN, JR.  
ARCHITECT

423 FISCHER TRAIL  
ELLIHAY, GEORGIA 30540

RELEASED FOR  
CONSTRUCTION

DATE	DESCRIPTION
10/30/17	CHECK SET

POPEYES  
HIGHWAY 441  
CORNELIA, GA 30531  
LOUISIANA KITCHEN LK-PLUS DESIGN STANDARDS  
60 SEATS / DUAL-LINE PRODUCTION JOB:17067



POPEYES

REVISIONS:

DATE: 9/23/13

M2

CHECKED: TM KR