
 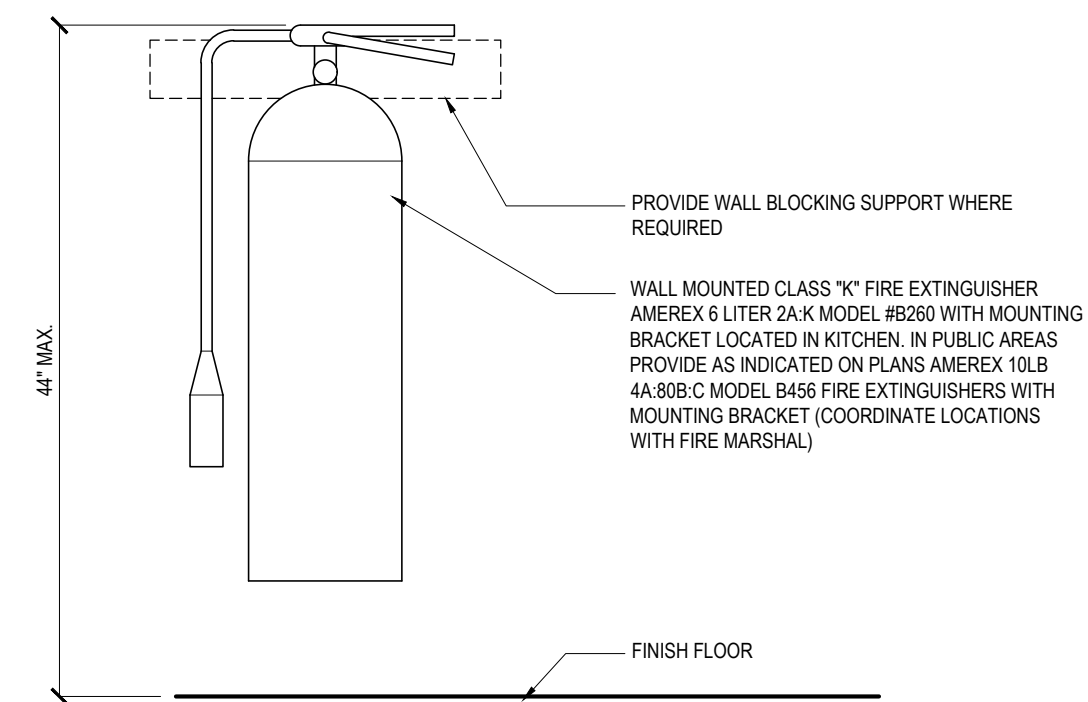


 

 
 



1. EXIT LIGHTS SHALL BE PROVIDED AT ALL EXTERIOR DOORS ALONG THE EGRESS PATH.
2. EMERGENCY LIGHTING SHALL BE PROVIDED AS REQUIRED BY CODE. REFER ELECTRICAL LIGHTING PLAN.
3. ALL DOOR HARDWARE SHALL MEET ALL APPLICABLE CODE REQUIREMENTS FOR EGRESS AND HANDICAP ACCESSIBILITY.
4. ALL DIMENSIONS SHOWN ON THIS PLAN ARE MINIMUM CLEAR DIMENSIONS.
5. GC SHALL INSTALL A KNOX BOX AT THE MAIN ENTRANCE. GC SHALL COORDINATE THE EXACT LOCATION, MOUNTING HEIGHT, AND TYPE WITH THE LOCAL FIRE OFFICIAL.
7. POST OCCUPANT LOAD PER LOCAL CODE. SEE COVER SHEET G-001 FOR OCCUPANT BREAKDOWN.




- 
- SYMBOL INDICATES ACCESSIBLE SEATING. AT EACH ACCESSIBLE SEAT, THE UNDERSIDE OF THE TABLE WILL BE 27" AFF MIN. THE TOP OF THE TABLE WILL BE 34" AFF MAX. A 30" WIDE WHEEL CHAIR WILL BE ABLE TO EXTEND UNDER THE TABLE A MIN. OF 19" FROM THE EDGE OF THE TABLE TOP.
- 
- SYMBOL INDICATES FIRE EXTINGUISHER (10 LB-440BC). WITH MOUNTING BRACKET. ONE EACH TO BE MOUNTED NEXT TO THE MAIN EXIT DOORS FROM THE MAIN BUILDING. MOUNT 44" AFF MAX. PROVIDE BLOCKING IN WALL FOR MOUNTING SUPPORT AS NEEDED. GC TO COORDINATE EXACT TYPE, LOCATION, AND MOUNTING HEIGHT WITH LOCAL FIRE OFFICIAL AS REQUIRED.
- 
- SYMBOL INDICATES "K" TYPE FIRE EXTINGUISHER WITH MOUNTING BRACKET. TO BE MOUNTED IN KITCHEN IN THE LOCATIONS INDICATED. MOUNT 44" AFF MAX. PROVIDE BLOCKING IN WALL FOR MOUNTING SUPPORT AS NEEDED. GC TO COORDINATE EXACT TYPE, LOCATION, AND MOUNTING HEIGHT WITH LOCAL FIRE OFFICIAL AS REQUIRED.
- 
- SYMBOL INDICATES EMERGENCY "EXIT" ILLUMINATED SIGN FIXTURE.
- 
- STARTING POINT OF MOST REMOTE POINT OF EGRESS
- 
- DOOR CLEAR OPENING  
EGRESS CAPACITY (PEOPLE)
- 
- EGRESS PATH
- 
- KNOX BOX


<u>TYPE OF SEATING</u>	
4 TOP TABLES	8 (4 SEATS) = 32 SEATS
2 TOP TABLES	3 (2 SEATS) = 6 SEATS
6 TOP TABLES	6 (6 SEATS) = 36 SEATS
<hr/>	
TOTAL	74 SEATS
<u>OUTDOOR SEATING</u>	
4 TOP FIXED TABLES	4 (4 SEATS) = 16 SEATS
TOTAL	16 SEATS
<b>GRAND TOTAL : INTERIOR &amp; EXTERIOR</b>	<b>90 SEATS</b>

**HANDICAP SEAT CALCULATION**  
 INTERIOR: 74 TOTAL SEATS x 5% = 4 REQUIRED / 4 PROVIDED  
 EXTERIOR: 16 TOTAL SEATS x 5% = 1 REQUIRED / 1 PROVIDED

SEATING CALCULATIONS	3
----------------------	---

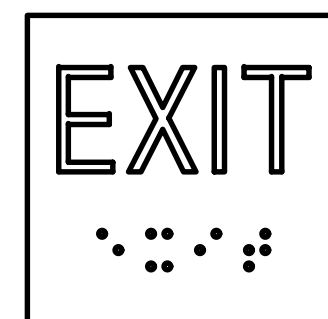

1. PROVIDE ONE TACTILE SIGN STATING "EXIT" NEXT TO EACH EXIT DOOR. SIGN SHALL COMPLY WITH ANSI A117.1.
2. SIGNS SHALL BE 6" X 6". LETTERS AND CHARACTERS SHALL BE WHITE. BACKGROUND SHALL BE BLACK.
3. LETTER WITH HEIGHT RANGE TO 3/5 MIN. TO 3/5 MIN. 11 MAX. STROKE WIDTH TO HEIGHT RATIO 1.5 TO 1.5 TO 10 MAX.
4. LETTERS SHALL BE SIMPLE SERIF TYPE, UPPERCASE, 2" HIGH AND SHALL BE RAISED 1/32".
5. BRAILLE CHARACTERS SHALL BE GRADE 2 BRAILLE. DOTS SHALL BE 1/16" ON CENTER IN EACH CELL, WITH 2/16" SPACE BETWEEN CELLS. DOTS SHALL BE RAISED A MINIMUM OF 1/40" ABOVE THE BACKGROUND.
6. SIGNS SHALL BE MOUNTED ON THE LATCH SIDE OF THE DOOR. SIGNS SHALL BE 60° AFF AND 9° FROM DOOR OPENING (EDGE MEASURED TO CENTER OF SIGN).

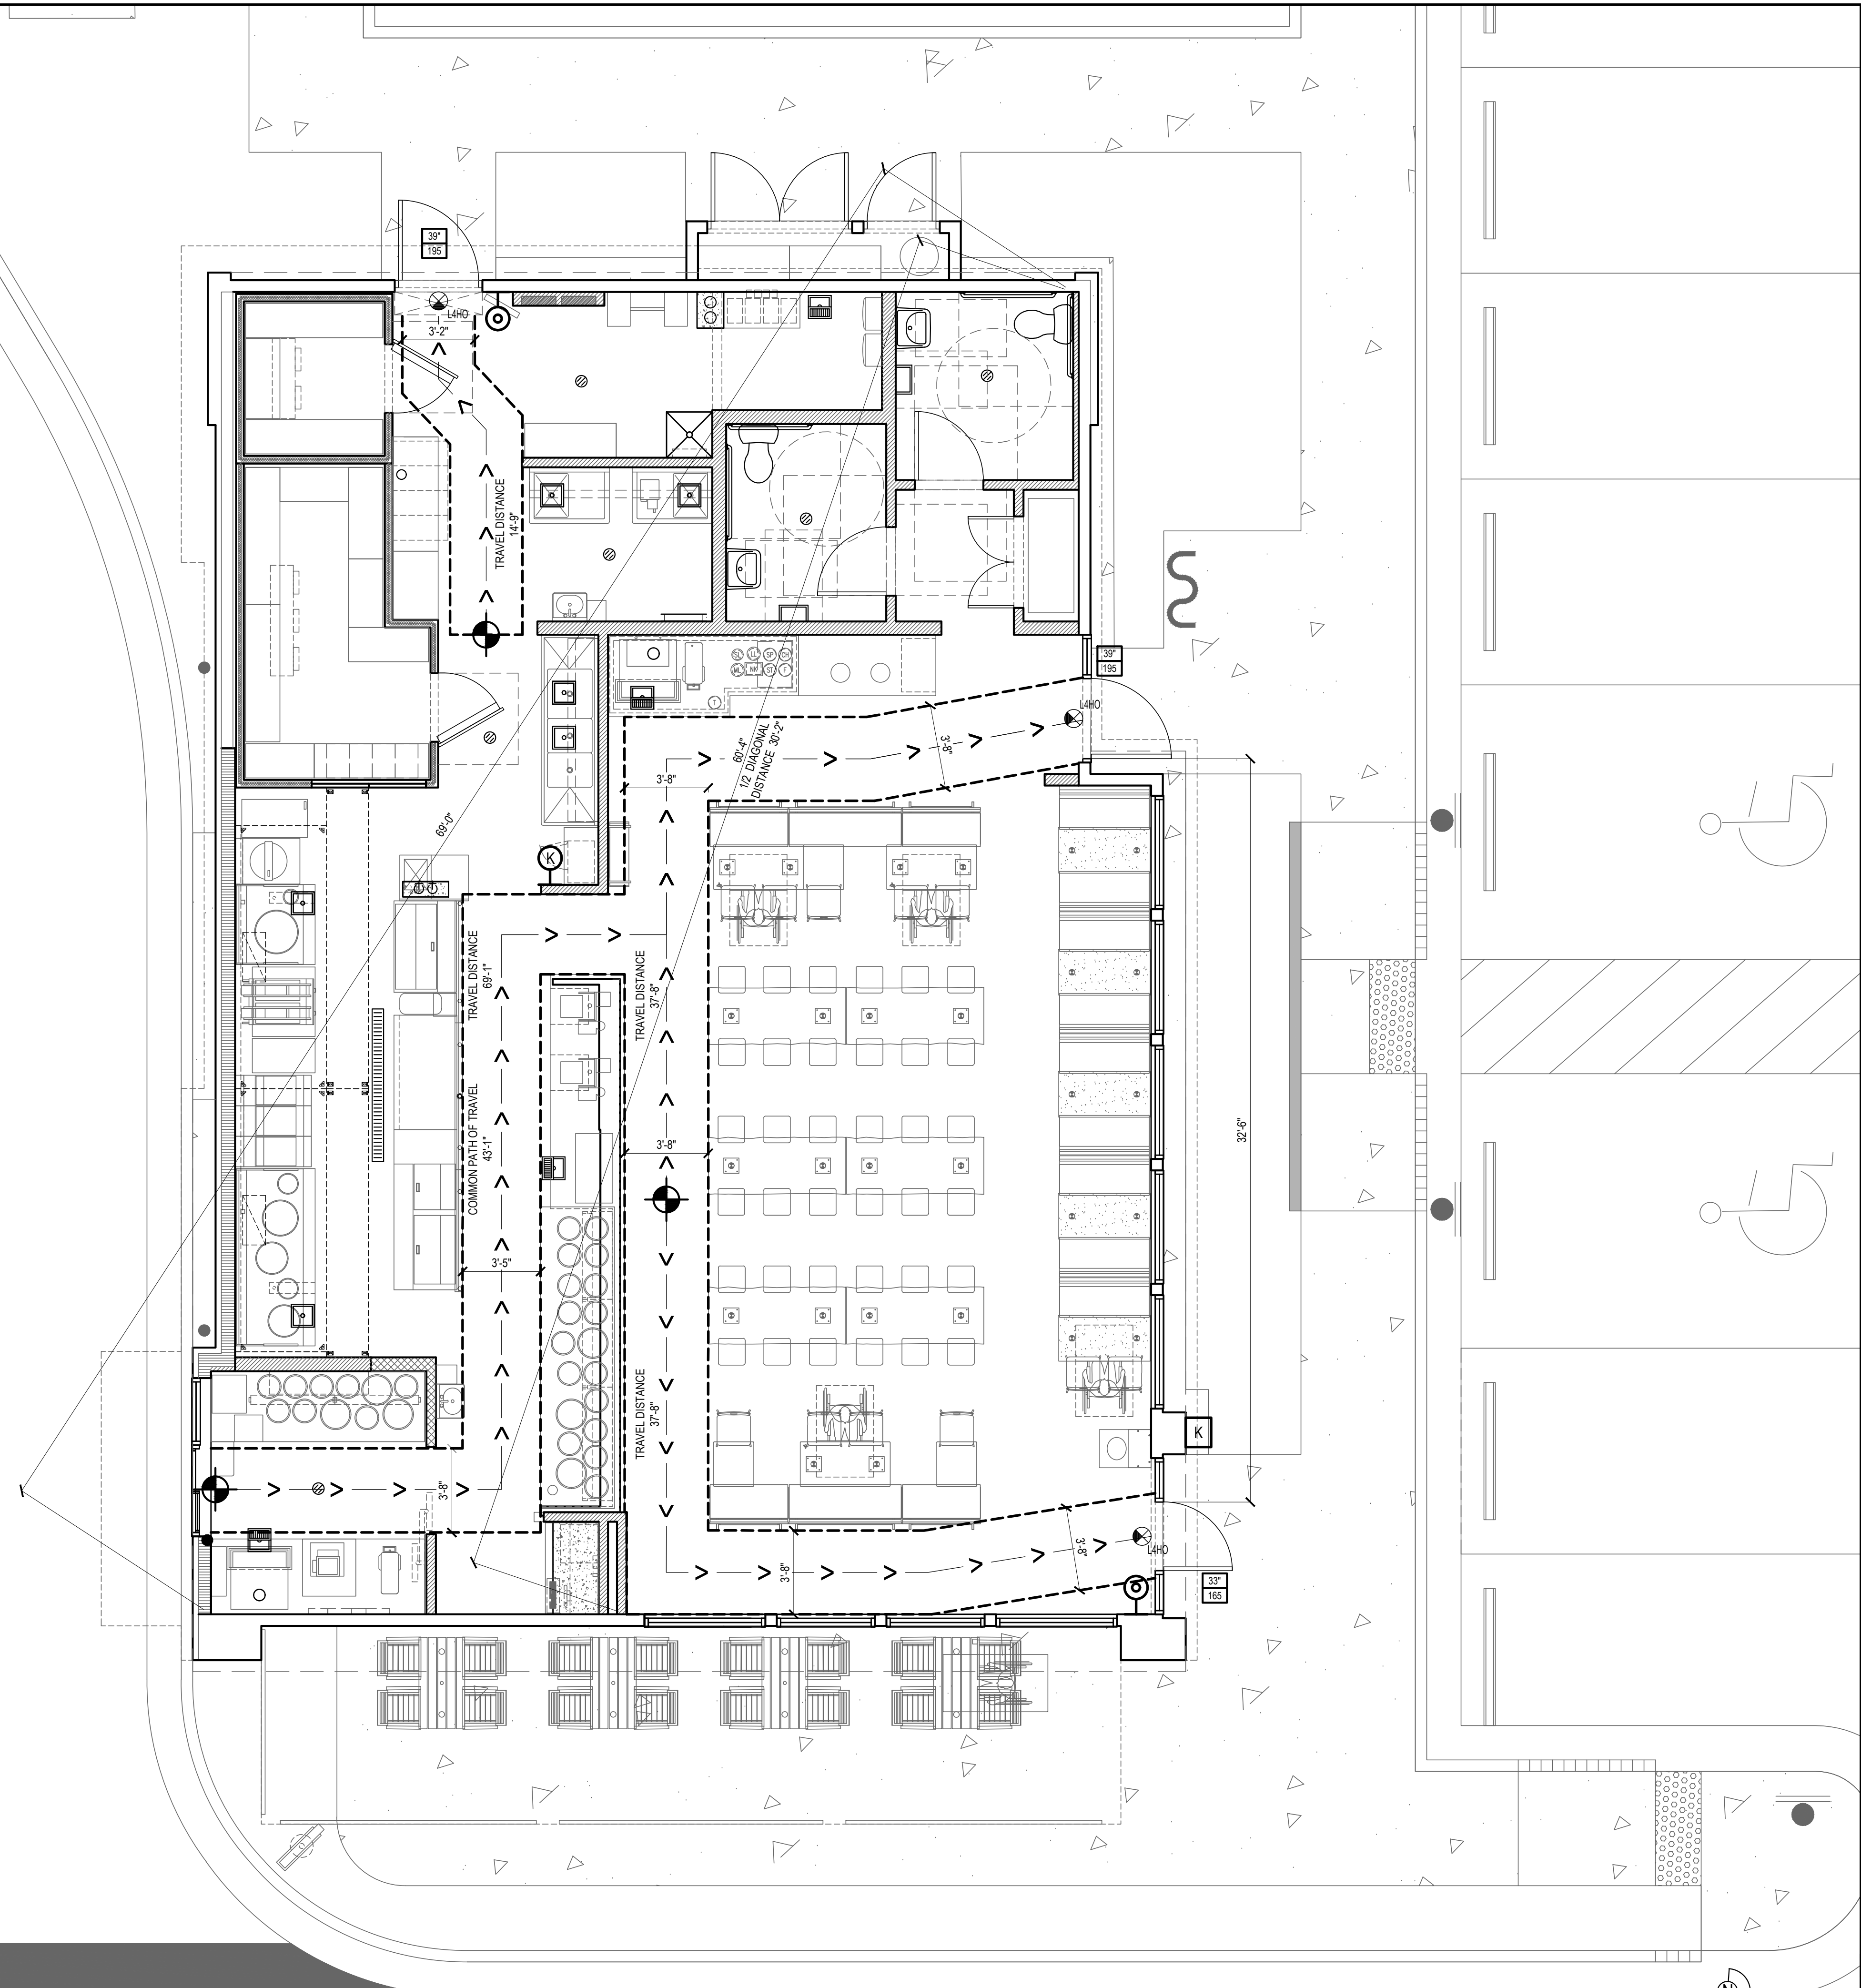

LIFE SAFETY PLAN	1
------------------	---

Scale= 1/4" = 1'-0"	LSP-101
---------------------	---------



PANDA RESTAURANT GROUP INC.  
1683 Walnut Grove Ave.  
Rosemead, California  
91770  
Telephone: 626.799.9898  
Facsimile: 626.372.8288

All ideas, designs, arrangement and plans indicated or represented by this drawing are the property of Panda Express Inc. and were created for use on this specific project. None of these ideas, designs, arrangements or plans may be used by or disclosed to any person, firm, or corporation without the written permission of Panda Express Inc.

REVISIONS:

[illegible]

ISSUE DATE:

1	04.29.2021 ISSUE FOR PERMIT
2	06.04.2021 ISSUE FOR BID

DRAWN BY: XXX

PANDA PROJECT #: - S8-22-D8135  
C&P PROJECT #: - 2200775



2600 Maitland Center Pkwy. Maitland, FL 32751  
P (407) 661-9100  
F (407) 661-9101  
**maecorp.com**  
Florida Company Consultants, LLC • C066634

06.04.2021

# PANDA EXPRESS

TRUE WARM AND WELCOME 2300  
SKYBROOKE BOULEVARD & STATE ROAD 54  
LUTZ, FL 33558

# LSP-101

LIFE SAFETY PLAN

TRUE WARM & WELCOME 2300 R4